


Luminaire Schedule								
Symbol	Qty	Label	Arrangement	Lum. Lumens	LLF	Description	Lum. Watts	Total Watts
☐	5	CPWP1	SINGLE	436	0.900	CPWP1 Wall Pack 8w	8.262	41.31

Calculation Summary								
Label	CalcType	Units	Avg	Max	Min	Avg/Min	Max/Min	
CalcPts_1	Illuminance	Lux	5.70	25.28	0.34	16.76	74.35	
2 x MH	Illuminance	Lux	7.43	25.28	1.52	4.89	16.63	

Not to Scale

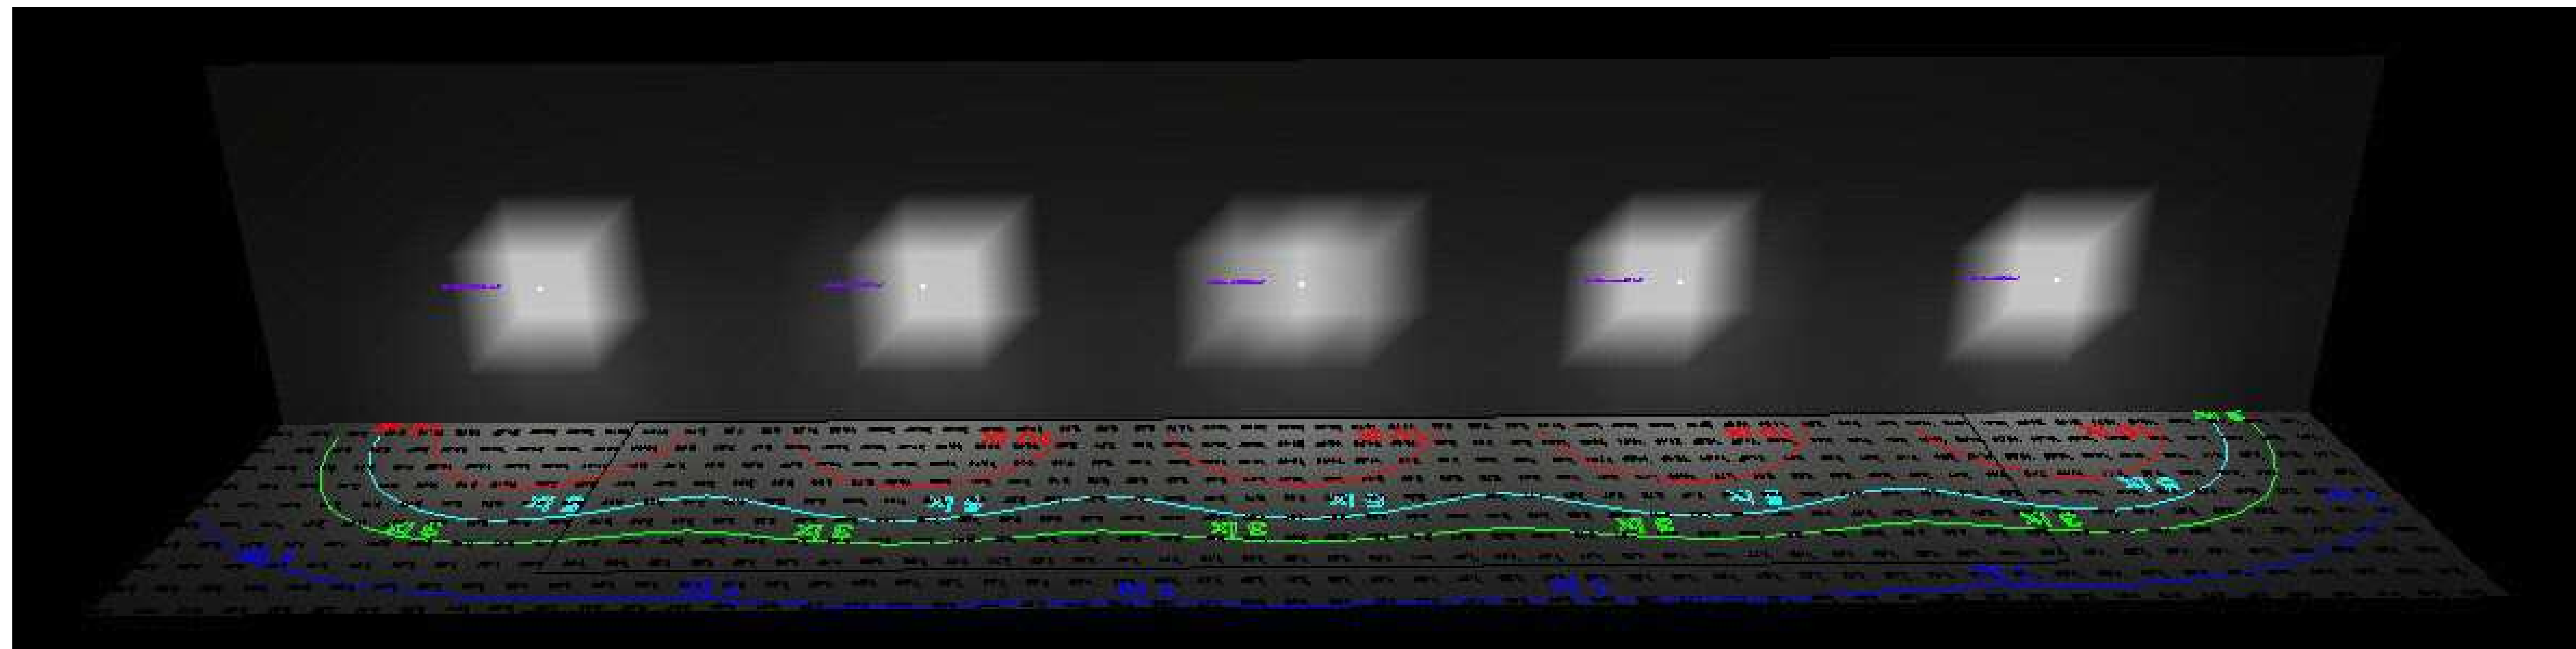

These drawings are for conceptual use only and are not intended for construction. Values represented are an approximation generated from manufacturers photometric inhouse or independent lab tests with data supplied by lamp manufacturers.

#	Date	Comments

Revisions

Drawn By: Joe Frey
Checked By:
Date: 12/16/2020
Scale: None

Test Description:
Perimeter Model CPWP1
Tested at 17V DC 20' Foot Spacing,
Lumiere 8' Feet Off Grade