


Luminaire Schedule								
Symbol	Qty	Label	Arrangement	Lum. Lumens	LLF	Description	Lum. Watts	Total Watts
■	7	CPWP2	SINGLE	1383	0.900	CPWP2 Wall Pack 13w	13.26	92.82

Calculation Summary								
Label	CalcType	Units	Avg	Max	Min	Avg/Min	Max/Min	
CalcPts FS16	ILLUMINANCE	Lux	30.47	58.86	5.81	5.24	10.13	
Copy 2 x MH	ILLUMINANCE	Lux	35.83	58.86	8.90	4.03	6.61	

Scale: 1 inch= 4 Ft.

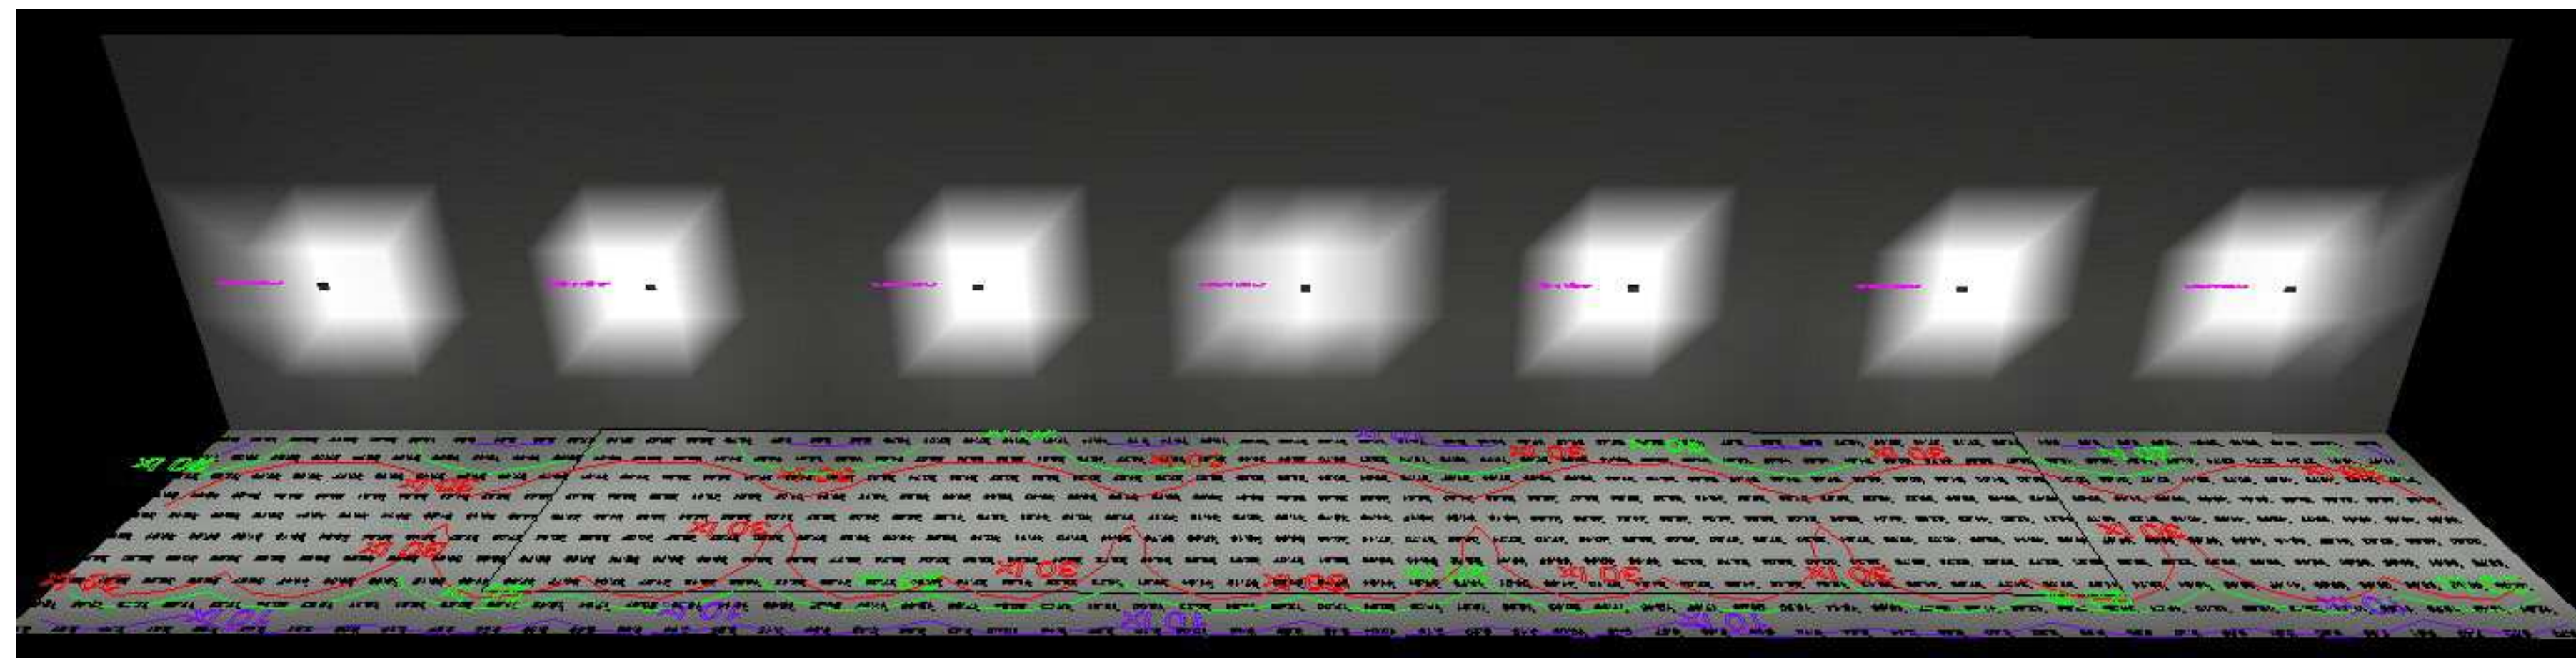

These drawings are for conceptual use only and are not intended for construction. Values represented are an approximation generated from manufacturers photometric inhouse or independent lab tests with data supplied by lamp manufacturers.

#	Date	Comments

Revisions	

Drawn By: Joe Frey
Checked By:
Date: 8/10/2021
Scale: None

Test Description:
Perimeter Model DC IFF CPWP2
Tested at 17V DC 16' Foot Spacing,
Lumiere 8' Feet Off Grade

CL973-3720