


Luminaire Schedule								
Symbol	Qty	Label	Arrangement	Lum. Lumens	LLF	Description	Lum. Watts	Total Watts
■	5	CPWP2	SINGLE	1383	0.900	CPWP2 Wall Pack 13w	13.26	66.3

Calculation Summary								
Label	CalcType	Units	Avg	Max	Min	Avg/Min	Max/Min	
CalcPts 1	Illuminance	Lux	20.25	37.23	1.30	15.58	28.64	
2 x MH A	Illuminance	Lux	22.40	37.23	5.33	4.20	6.99	

Not to Scale

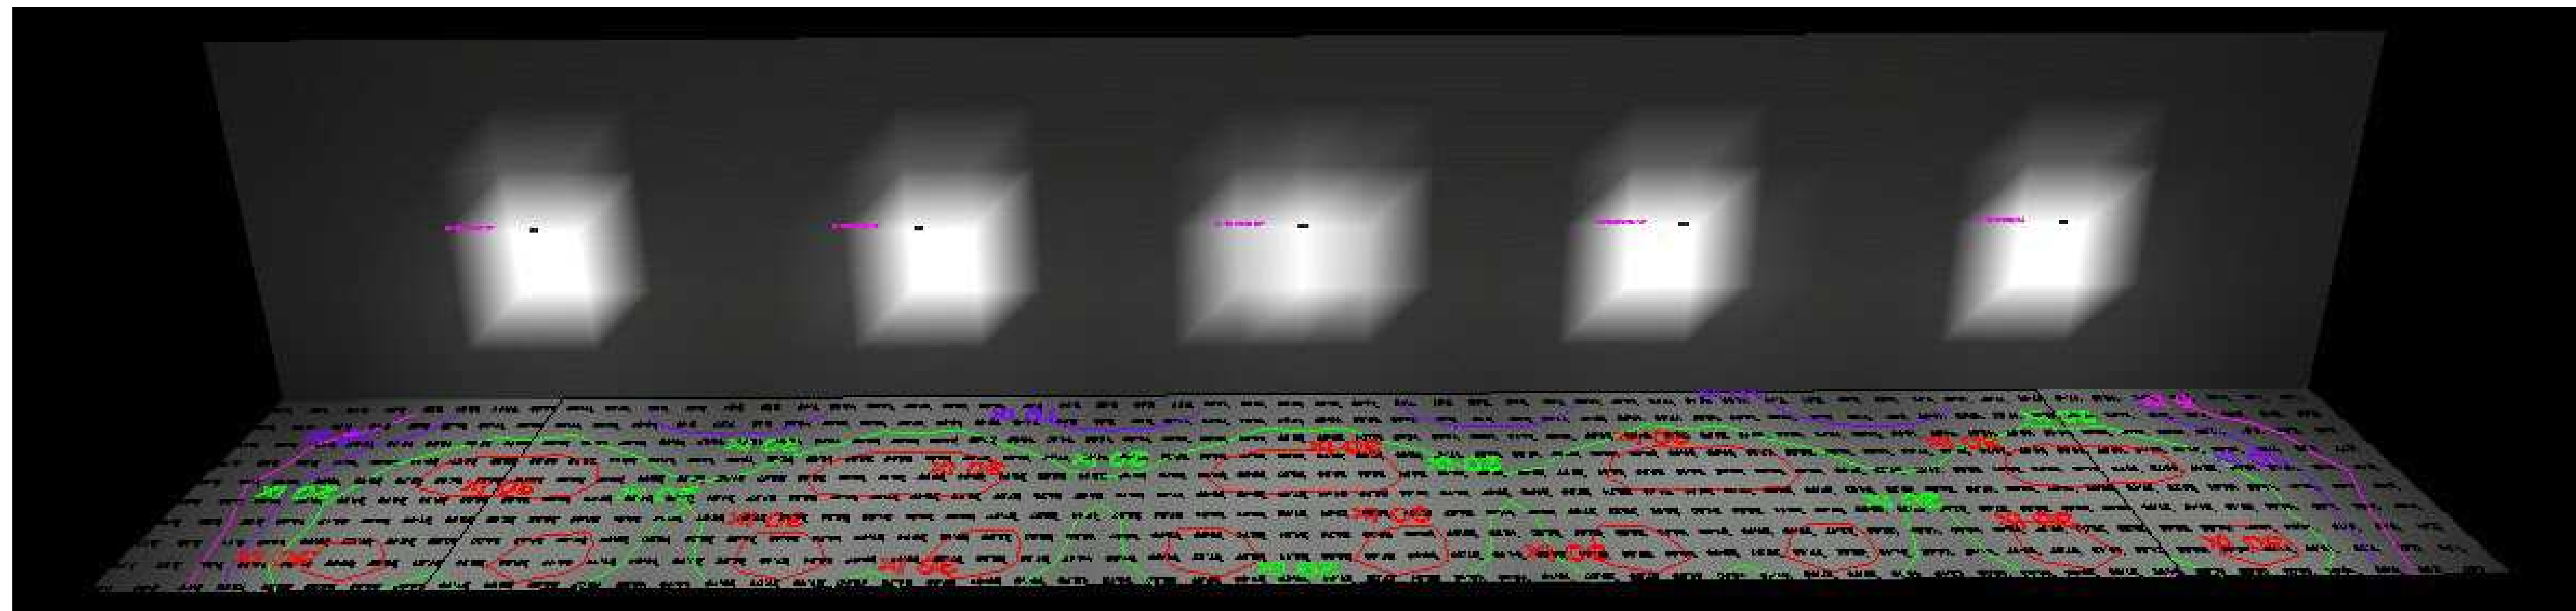

These drawings are for conceptual use only and are not intended for construction. Values represented are an approximation generated from manufacturers photometric inhouse or independent lab tests with data supplied by lamp manufacturers.

#	Date	Comments

Revisions

Drawn By: Joe Frey
Checked By:
Date: 12/16/2020
Scale: None

Test Description:
Perimeter Model CPWP2
Tested at 17V DC 20' Foot Spacing,
Lumiere 10' Feet Off Grade