

79.5

75.5

71.5

67.5

63.5

59.5

55.5

51.5

47.5

43.5

39.5

35.5

31.5

27.5

23.5


19.5

15.5

11.5

7.5


3.5

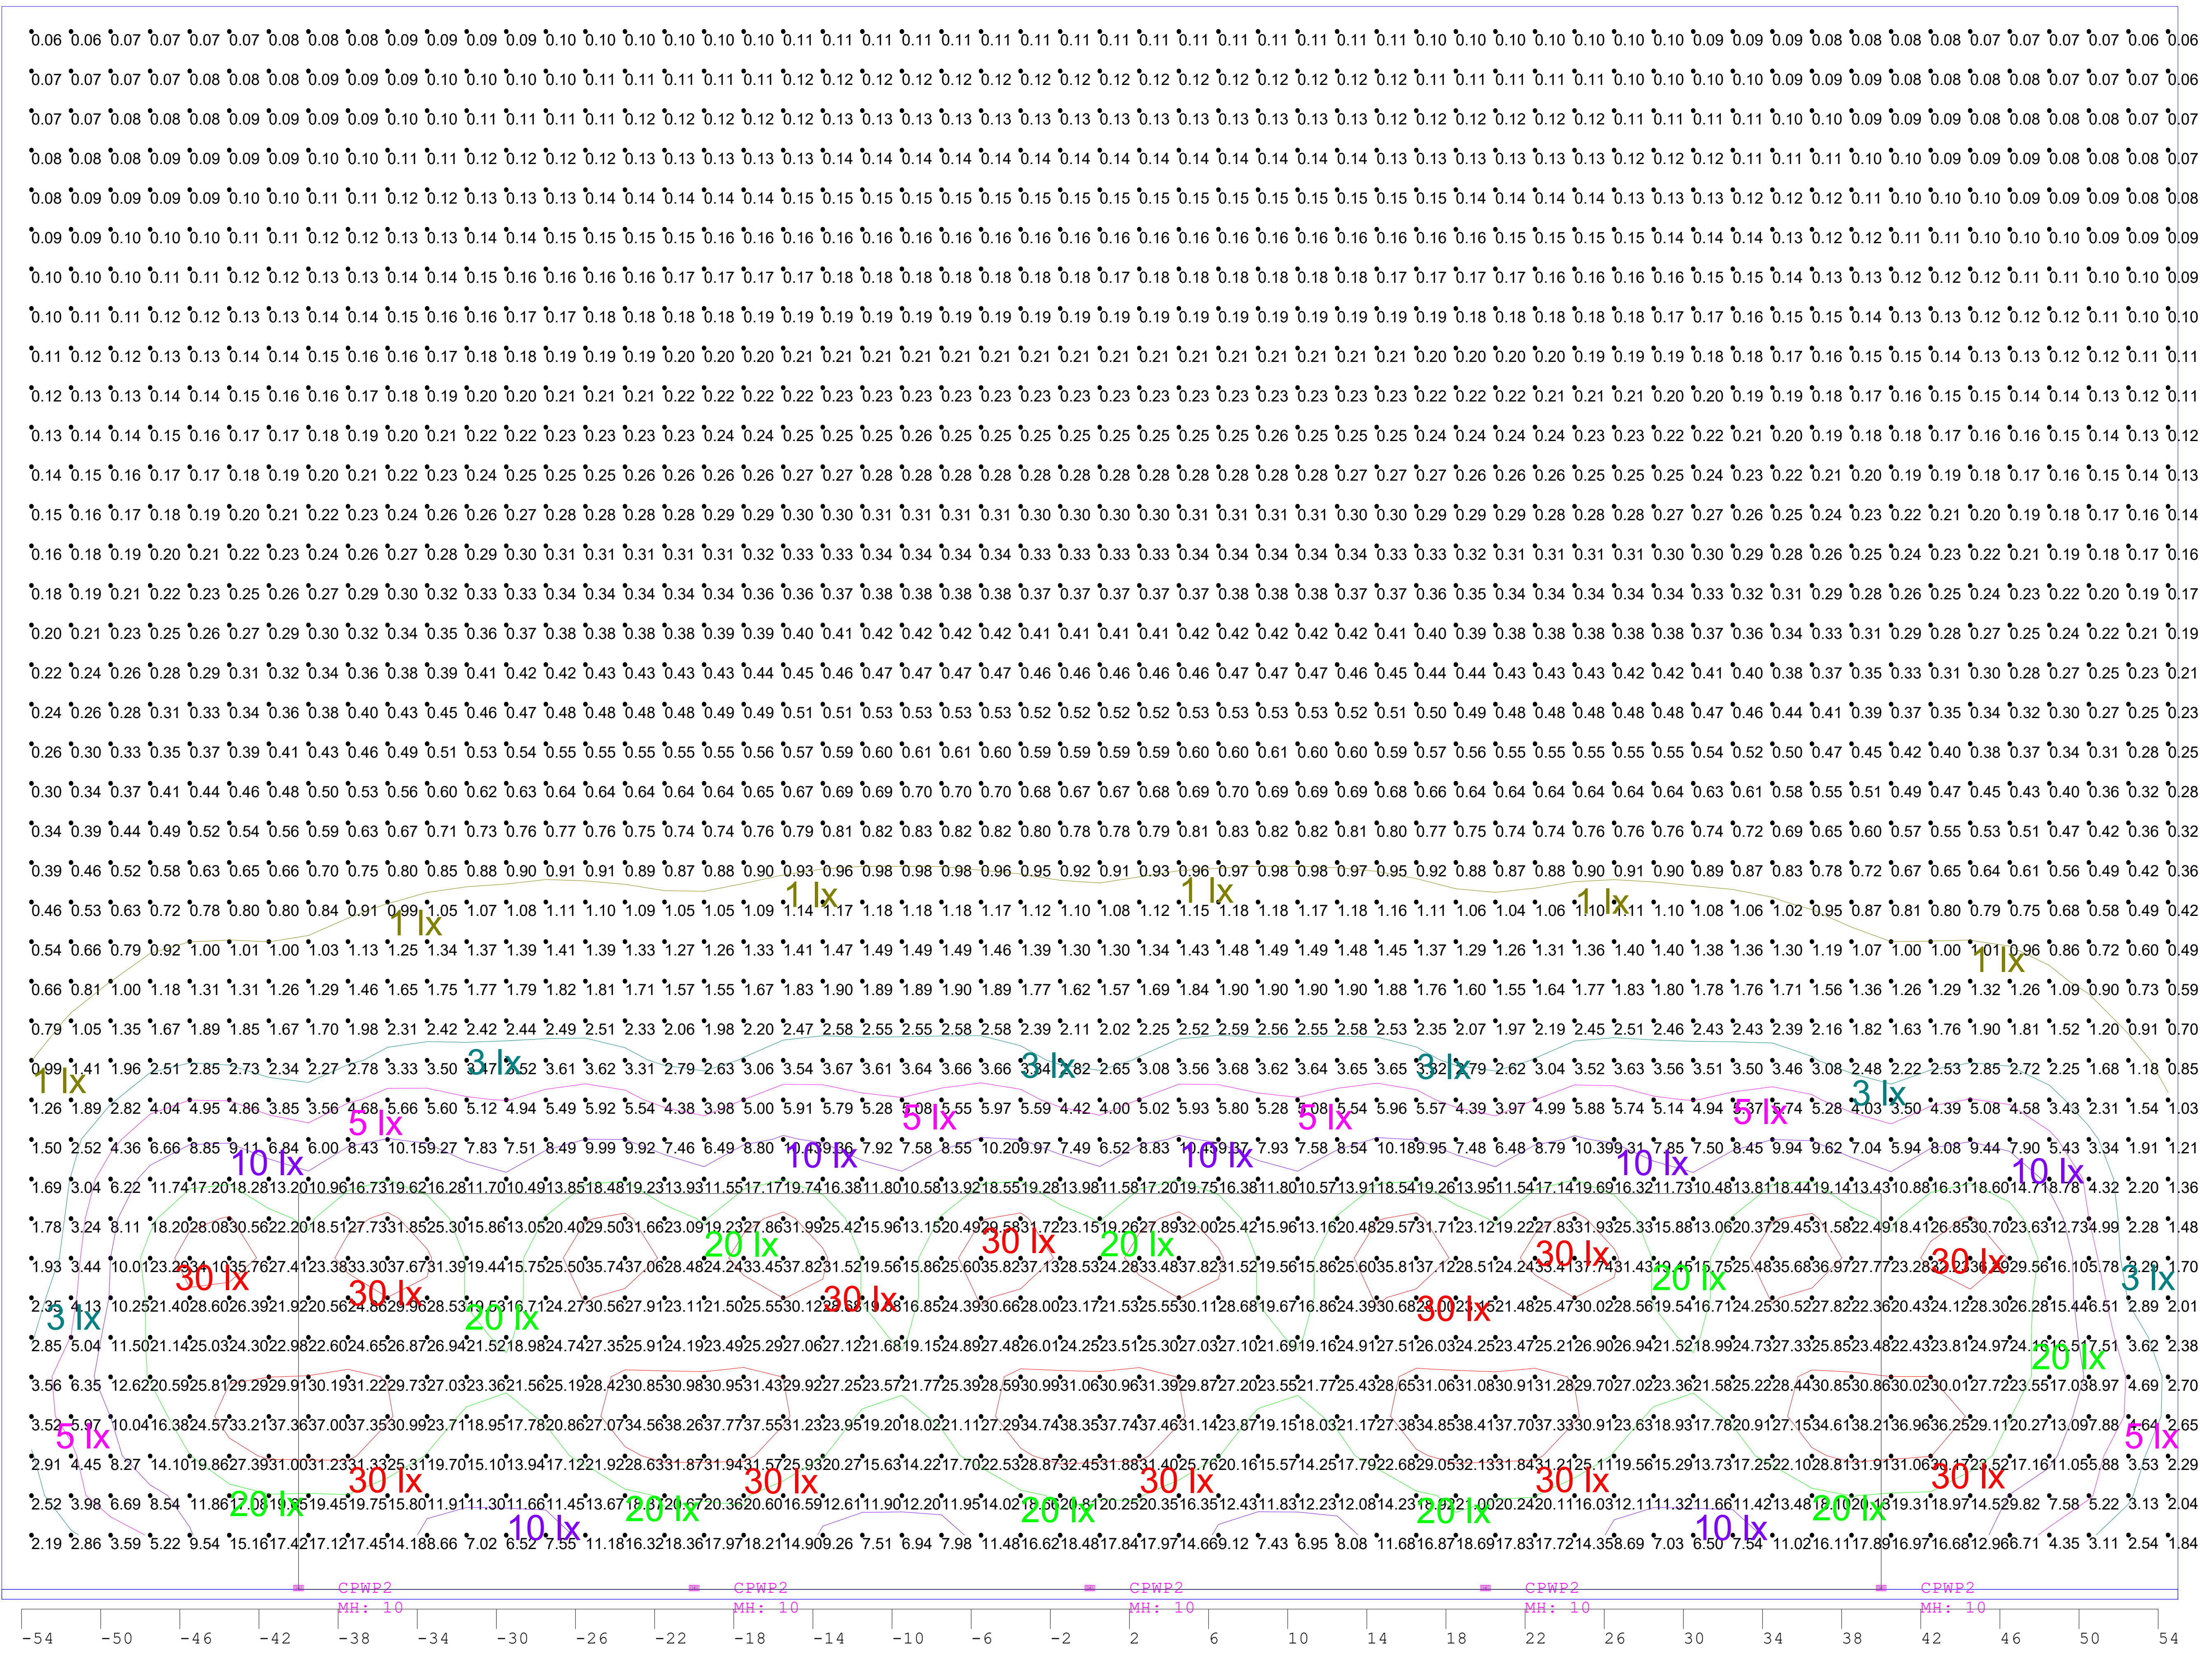

Luminaire Schedule						
Symbol	Qty	Label	Arrangement	Lum. Lumens LLF	Description	Total Watts
■	5	CPWP2	SINGLE	1383	CPWP2 Wall Pack 13w	66.3

Calculation Summary							
Label	CalcType	Units	Avg	Max	Min	Avg/Min	Max/Min
CalcPts CPWP2	Illuminance	Lux	5.95	38.41	0.06	99.17	640.17
2 x MH_A	Illuminance	Lux	23.44	38.41	6.50	3.61	5.91

Scale: 1 inch = 4 Ft.

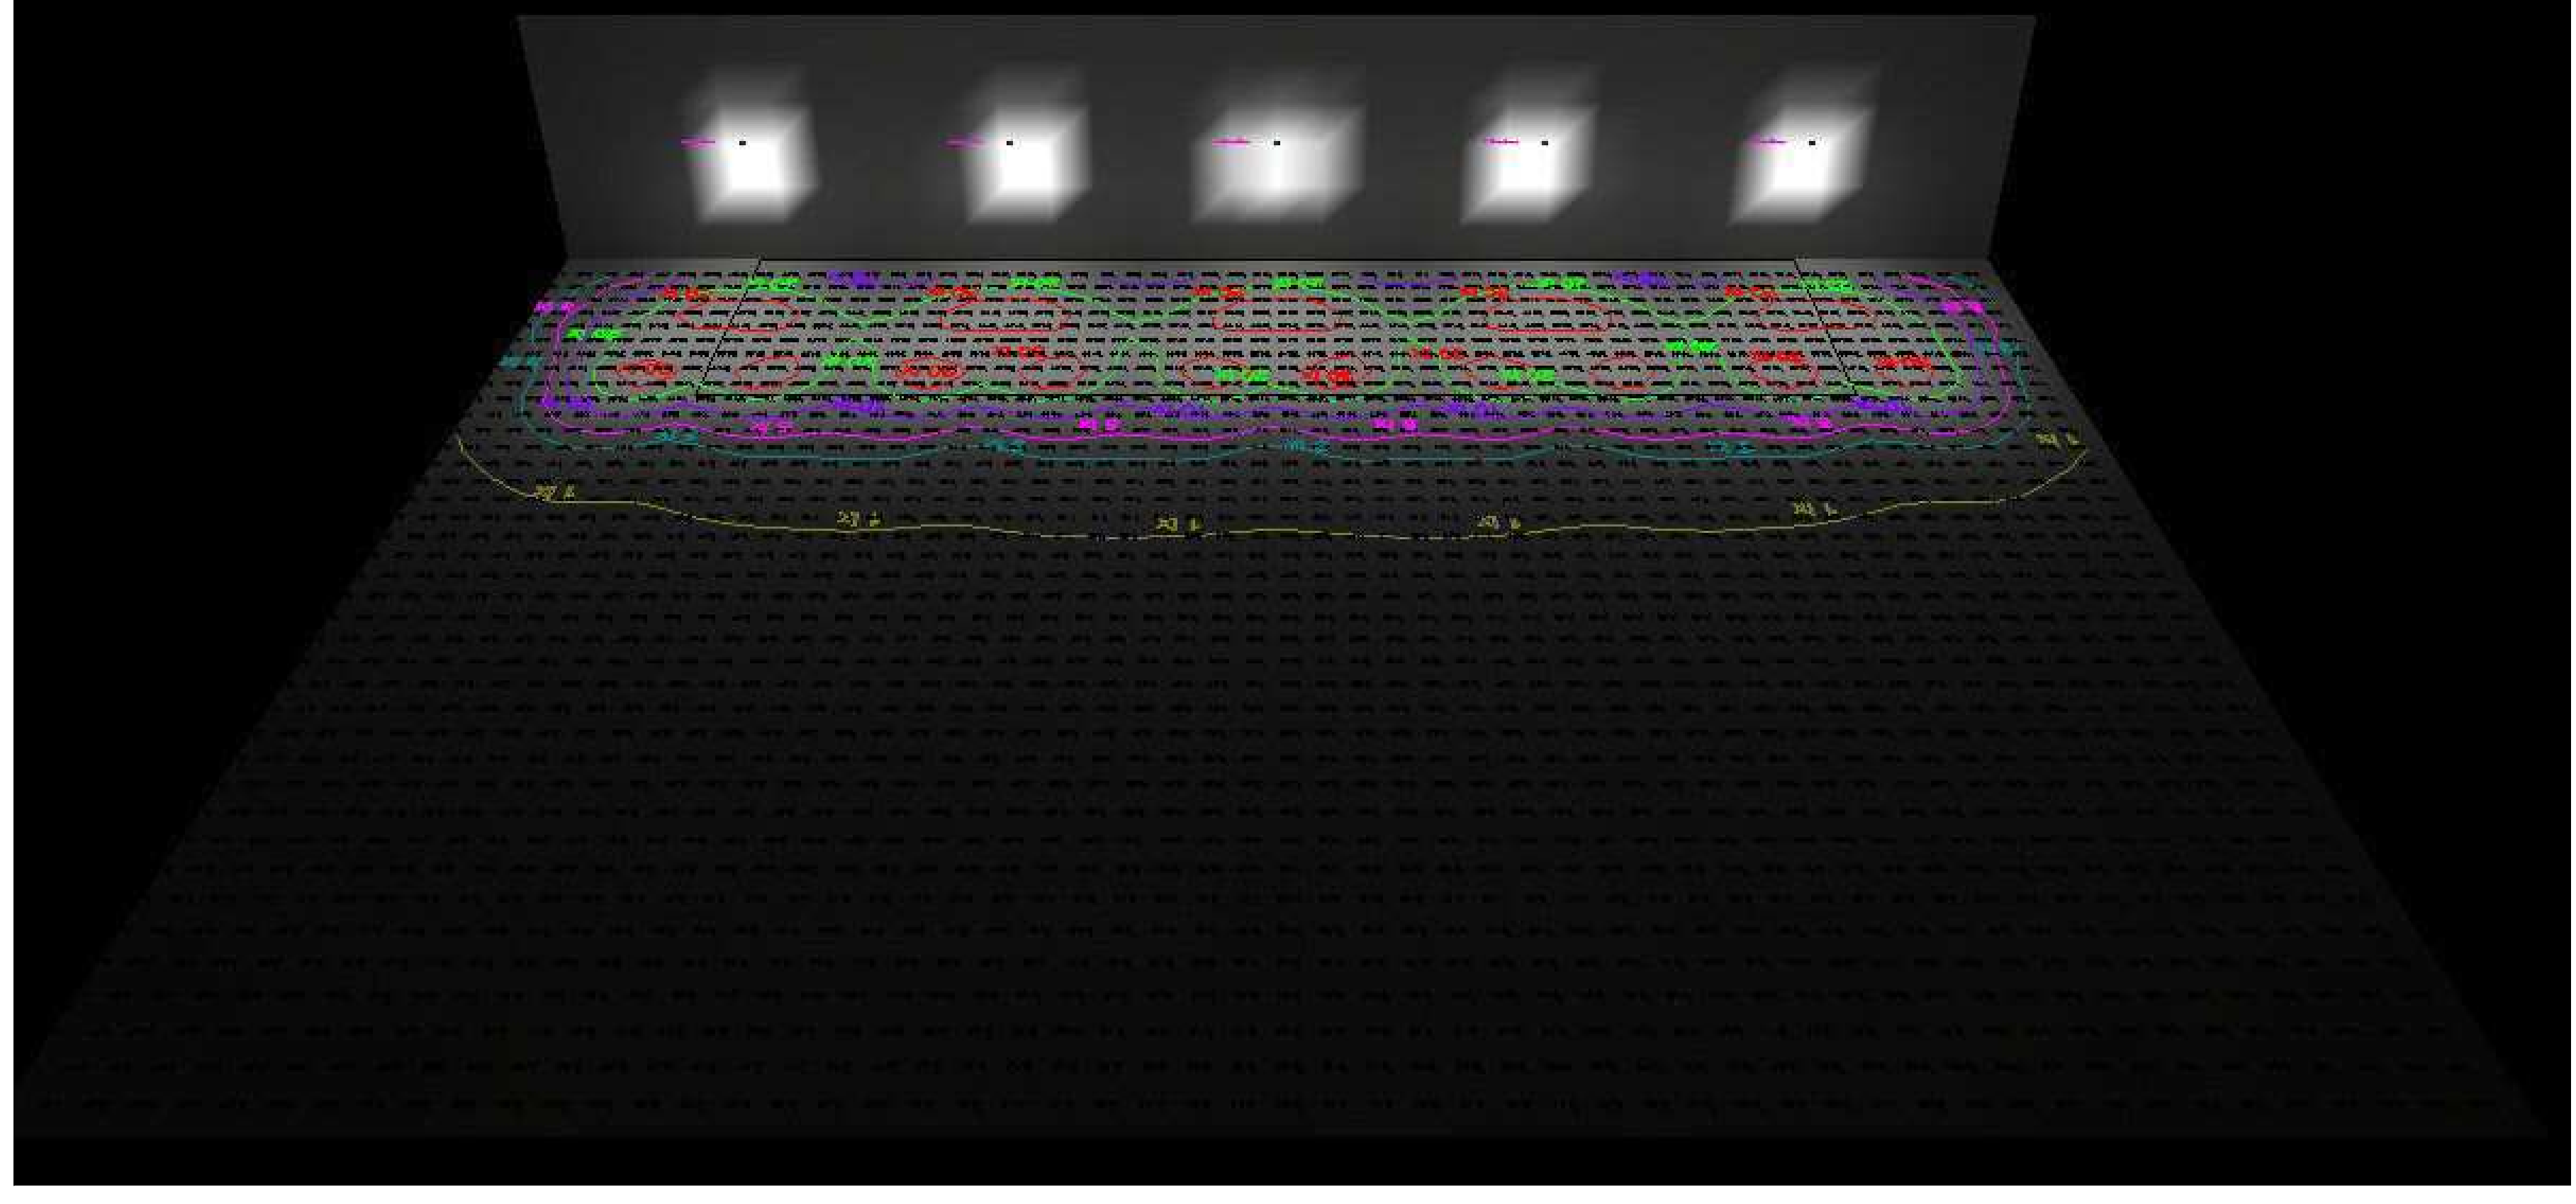

These drawings are for conceptual use only and are not intended for construction. Values represented are an approximation generated from manufacturers photometric inhouse or independent lab tests with data supplied by lamp manufacturers.



Revisions	
#	Date

Drawn By: Joe Frey
Checked By:
Date: 12/17/2020
Scale: None

Test Description:
 Perimeter Model CPWP2
 Tested at 17V DC 20' Foot Spacing,
 Luminaire 10' Feet Off Grade