


Luminaire Schedule							
Symbol	Qty	Label	Arrangement	Lum. Lumens	LLF	Description	Total Watts
■	5	CPWP2	SINGLE	1383	0.900	CPWP2 Wall Pack 13w	66.3

Calculation Summary							
Label	CalcType	Units	Avg	Max	Min	Avg/Min	Max/Min
CalcPts FS24	Illuminance	Lux	21.60	56.47	2.86	7.55	19.74
2 x MH FS24	Illuminance	Lux	23.04	56.47	3.95	5.83	14.30

Scale: 1 inch= 4 Ft.

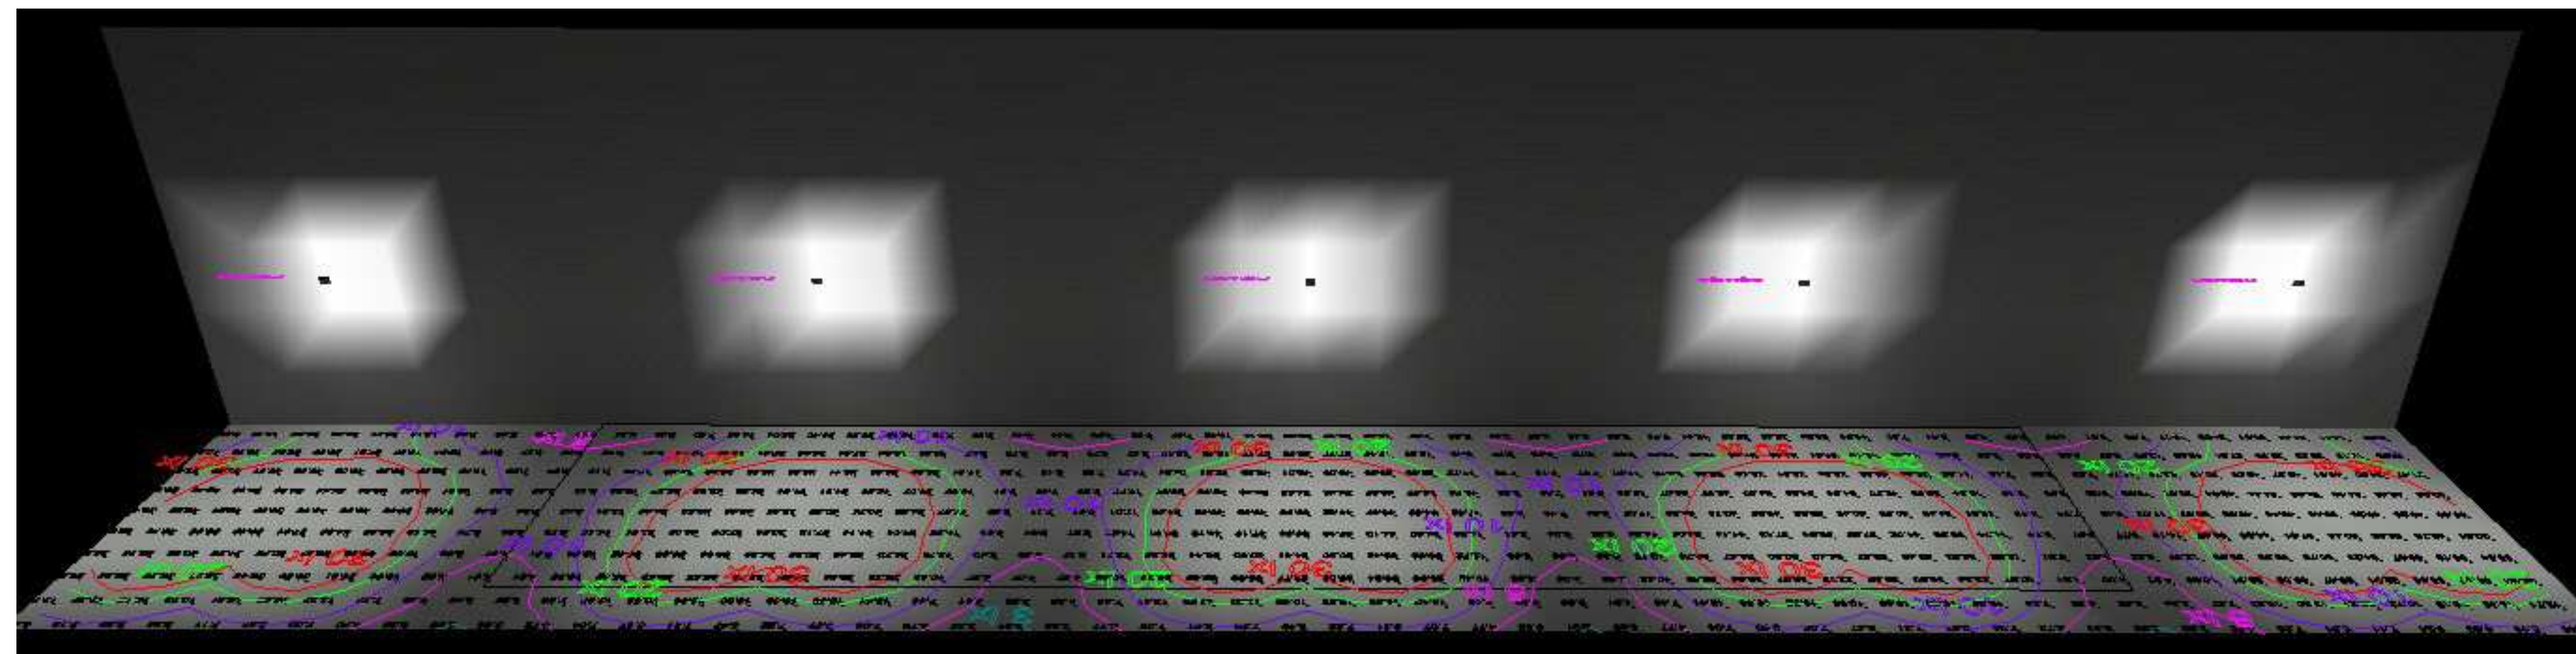

These drawings are for conceptual use only and are not intended for construction. Values represented are an approximation generated from manufacturers photometric inhouse or independent lab tests with data supplied by lamp manufacturers.

#	Date	Comments

Revisions	

Drawn By: Joe Frey
Checked By:
Date: 8/10/2021
Scale: None

Test Description:
Perimeter Model DC IFF CPWP2
Tested at 17V DC 24' Foot Spacing,
Lumiere 8' Feet Off Grade